

TEACHING ROOMS 18+ SEATS
8 SYSTEMS TOTAL

CONTROL SCHEMATIC

RACK


SMART SYMPODIUM ID-350

USB
RGBHV
INTERACTIVE LCD SCREEN


NEC LCD4020
RGBHV
AUDIO
LCD SCREEN

NEC SPEAKERS

14 RU RACK
TEAMMATE TRAINER

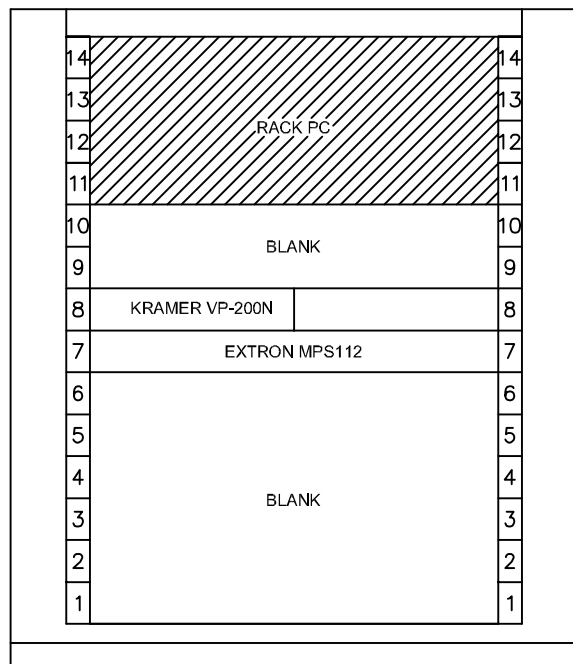

EQUIPMENT ON TOP OF TEAMMATE TRAINER

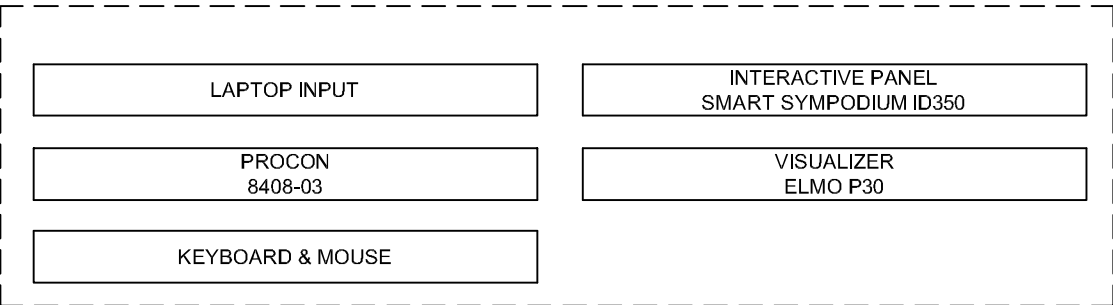

EQUIPMENT RACK INFORMATION	
MAKE	TEAMMATE
MODEL	TRAINER
RACK TOP	
RACK SIDES	
CASTORS	
CABLE TYPES	ASYSCO STANDARD
RACK > SITE 2m TAILS - FEMALE CONNECTORS	
RACK > TROLLEY 8m TAILS - MALE CONNECTORS	

AB	AS BUILT	17.09.08
D	CABLE, CONNECTOR DETAILS ADDED	08.09.08
C	EXTRON MPS112 REPLACED KRAMER VP23C	05.09.08
B	DWG MOD	08.08.08
A	ADDED LAN CONNECTIONS	29.07.08
-	FIRST DRAWN	16.07.08
REV	REVISION NOTE	DATE

ISSUE REASON:
AS BUILT



Asysco House, Omega Way
Surrey TW20 8RD
Tel: (01784) 487000 Fax: (01784) 487060

PROJECT:	SUFFOLK UNIVERSITY		
AREA:	TEACHING ROOMS 18+ SEATS		
TITLE:	VIDEO AUDIO CONTROL SCHEMATIC		
DRAWING NUMBER:	D2900-0436		
SALES SEQ NUMBER:	PROJECT DESIGN NUMBER:		
	D2900		
SCALE: NTS	ALL DIMENSIONS IN mm UNLESS OTHERWISE STATED		
CHECKED: MB	APPROVED: HC	DRAWN BY: AB	REV:

U:\PROJECT DESIGNS\SUFFOLK UNIDESIGN\ - TEACHING ROOMS 18+ SEATS\D2900-0436.dwg