

CLASSROOM 30 SEATS  
5 SYSTEMS

RACK

CONTROL SCHEMATIC

RACK

PROCON 8408-03

XPORT (RS232 1)

PORT 3 (RS232 2)

POWER PROGRAMING

CONTROLLER

C11

C12

D9(M)

D02

LAN

CAT 5

I/P PLATE

LAN

CAT 5

RACK PC

USB

USB (A)

USB (B)

RGBHV

V11

RGBHV

RGBHV

RGBHV

1:2 VDA

A11,2

AUDIO

A11,2

AUDIO

EQUIPMENT ON TOP OF TEAMMATE TUTOR

LAPTOP INPUT

INTERACTIVE PANEL  
SMART SYMPODIUM ID350

PROCON  
8408-03


VISUALIZER  
ELMO P30

KEYBOARD & MOUSE

EQUIPMENT RACK INFORMATION

MAKE	TEAMMATE
MODEL	TUTOR 14X500
RACK TOP	
RACK SIDES	
CASTORS	
CABLE TYPES	ASYSCO STANDARD
RACK > RACK	
RACK > SITE	2m TAILS - FEMALE CONNECTORS

14 RU RACK  
TEAMMATE TUTOR 14X500

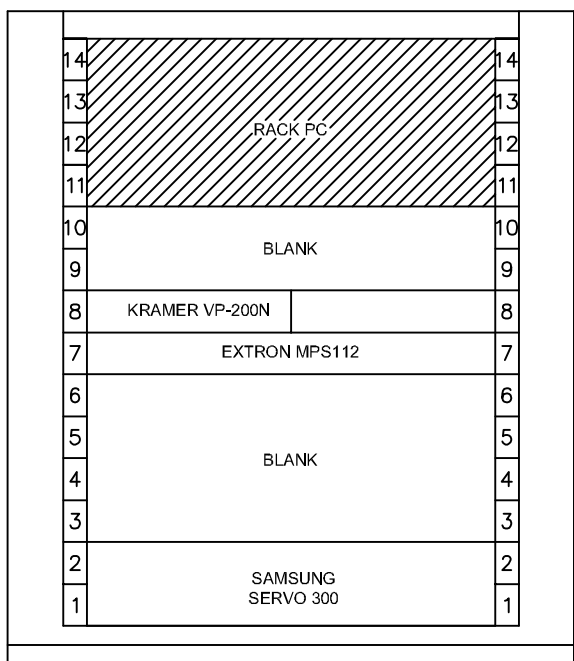

AB	AS BUILT	17.09.08
E	CABLE, CONNECTOR DETAILS ADDED	08.09.08
D	EXTRON MPS112 REPLACED KRAMER VP23C	05.09.08
C	DWG MOD, SAMSUNG REPLACED DENON	08.08.08
B	ADDED LAN CONNECTIONS	01.08.08
A	ADDED DENON AMP AND CHANGED SPEAKERS	29.7.08
-	FIRST DRAWN	16.07.08
REV	REVISION NOTE	DATE

ISSUE REASON:  
**AS BUILT**



Asysco House, Omega Way  
Surrey TW20 8RD  
Tel: (01784) 487000 Fax: (01784) 487060

PROJECT: SUFFOLK UNIVERSITY

AREA: CLASSROOM 30 SEATS

TITLE: VIDEO AUDIO CONTROL SCHEMATIC

DRAWING NUMBER: D2900-0336

SALES SEQ NUMBER: PROJECT DESIGN NUMBER: D2900

SCALE: NTS ALL DIMENSIONS IN mm UNLESS OTHERWISE STATED

CHECKED: MB	APPROVED: HC	DRAWN BY: AB	REV:
-------------	--------------	--------------	------

